


COLD & HOT WATER

SCALE: 1/4"=1'-0"

REFERENCE NOTES:

- ① EXIST. 3" CW, FOR CONT. SEE SITE PLAN
- ② EXIST. 3" CW, UP
- ③ EXIST. 2 1/2" CW, DN
- ④ EXIST. 2 1/2" CW, UP 30" ABOVE FINISH GRADE
- ⑤ EXIST. HB (TYP.)
- ⑥ EXIST. 2 1/2" CW BELOW GRADE
- ⑦ NEW 3/4" C/HW ABOVE CLG. (TYP.)
- ⑧ NEW 1/2" CW ABOVE CLG.
- ⑨ EXIST. 1 1/4" CW & 1" HW
- ⑩ EXIST. 3/4" C/HW
- ⑪ 3" CW, 1 1/4" HW & 3/2" HWR (E)
- ⑫ 3" CW, 1" HW & 1/2" HWR (E)

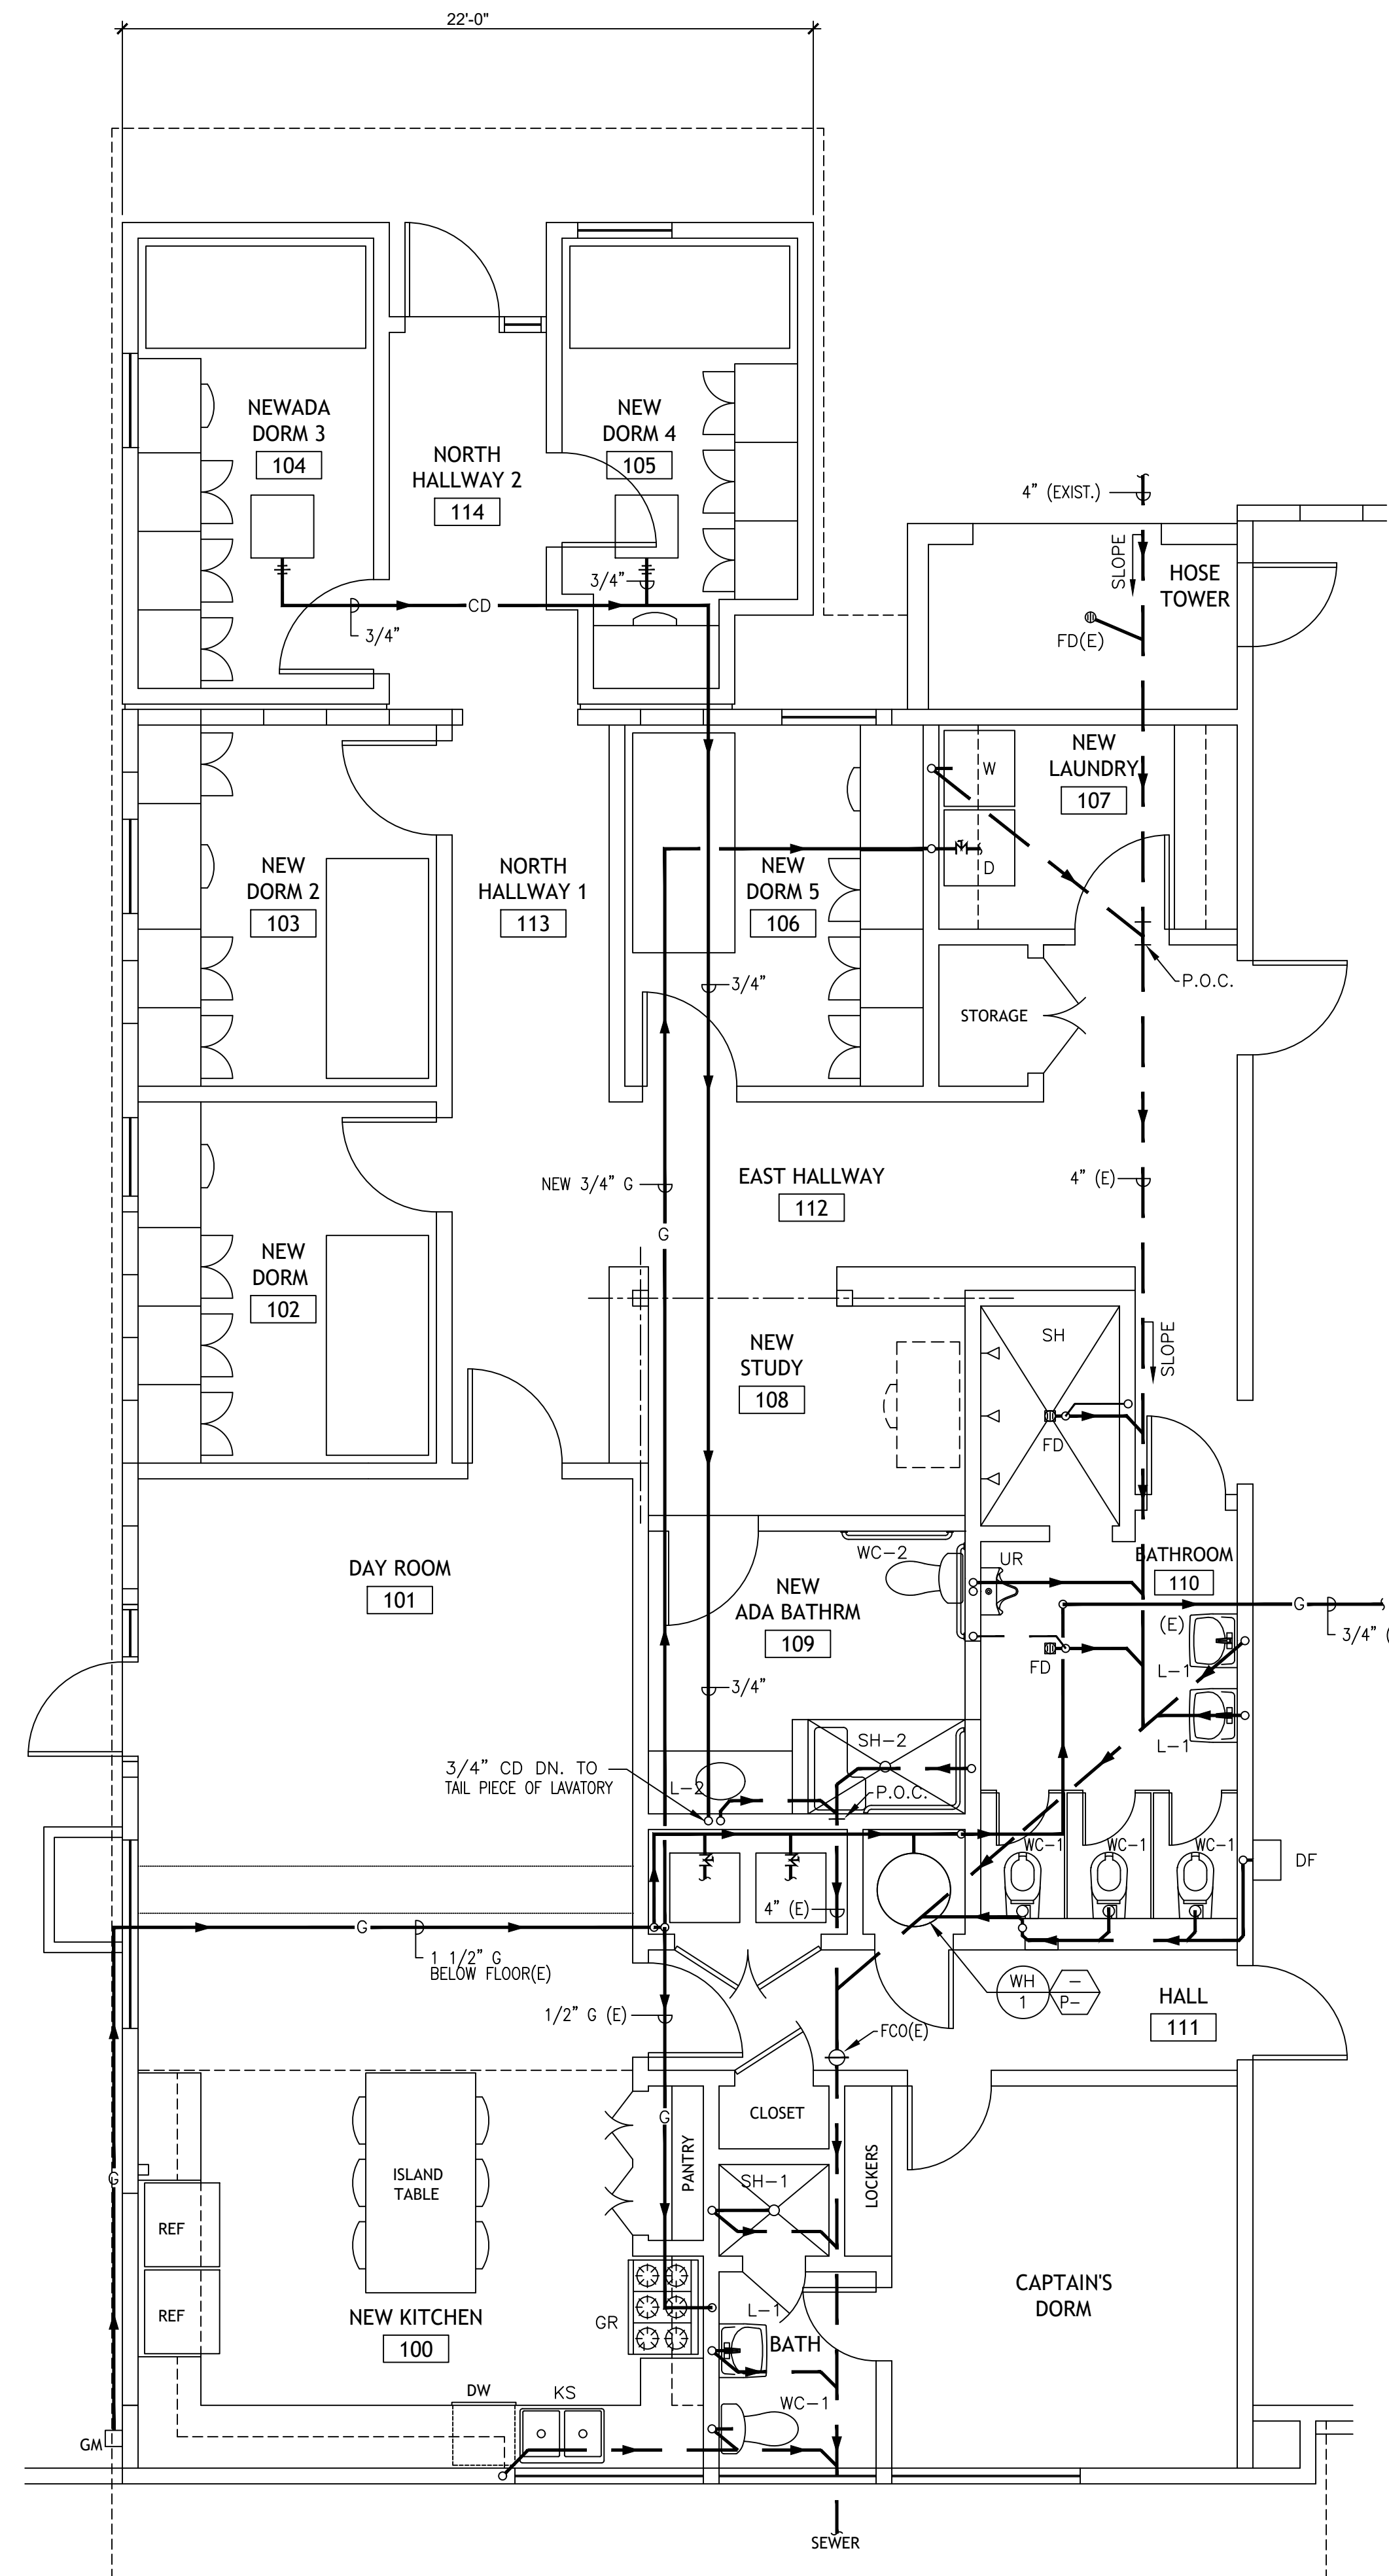

GAS & SEWER

SCALE: 1/4"=1'-0"



CURESH ENGINEERING
 Mechanical Consultant
 1659 Wellesley Avenue TEL: (310) 775-7662
 Los Angeles, CA 90025
 E-mail: curesh-engineering@sbglobal.net

WILLIAM LOYD JONES ARCHITECT
 9415 uliver boulevard
 los angeles, california
 90232

TEL 910 392 3995

FLOOR PLANS
CITY OF TORRANCE
FIRE DEPARTMENT
FIRE STATION 4 RENOVATION
 5205 CALLE MAYOR
 TORRANCE, CA 90505

Issue	

THE ABOVE DRAWINGS AND SPECIFICATIONS AND IDEAS, DESIGN AND ARRANGEMENTS REPRESENTED THEREBY ARE AND SHALL REMAIN THE PROPERTY OF THE ARCHITECT AND NO PART THEREOF SHALL BE COPIED, REPRODUCED OR OTHERWISE USED IN CONNECTION WITH ANY PROJECT OTHER THAN THE SPECIFIC PROJECT FOR WHICH THEY HAVE BEEN PREPARED AND DEVELOPED WITHOUT THE WRITTEN CONSENT OF THE ARCHITECT. VISUAL CONFIDENCE WITH THESE DRAWINGS OR SPECIFICATIONS SHALL CONSTITUTE CONCLUSIVE EVIDENCE OF ACCEPTANCE OF THESE RESTRICTIONS.

WRITTEN COMMENT ON THESE DRAWINGS SHALL BE RECEIVED OVER SCALED DIMENSIONS. CONTRACTORS SHALL VERIFY AND BE RESPONSIBLE FOR ALL DIMENSIONS AND CONDITIONS ON THE JOB AND NOT SPECIFIED HEREIN. ANY AND ALL VARIATIONS FROM THE JOB AND NOT SPECIFIED SHOWN BY THESE DRAWINGS, SHOP DETAILS MUST BE SUBMITTED TO THIS OFFICE FOR APPROVAL, BEFORE PROCEEDING WITH FABRICATION.

Copyright 2004

Date	01.SEP.21
Drawn	FG
Checked	CD
Scale	1/4"=1'-0"
Job. No.	--

P-2.1